
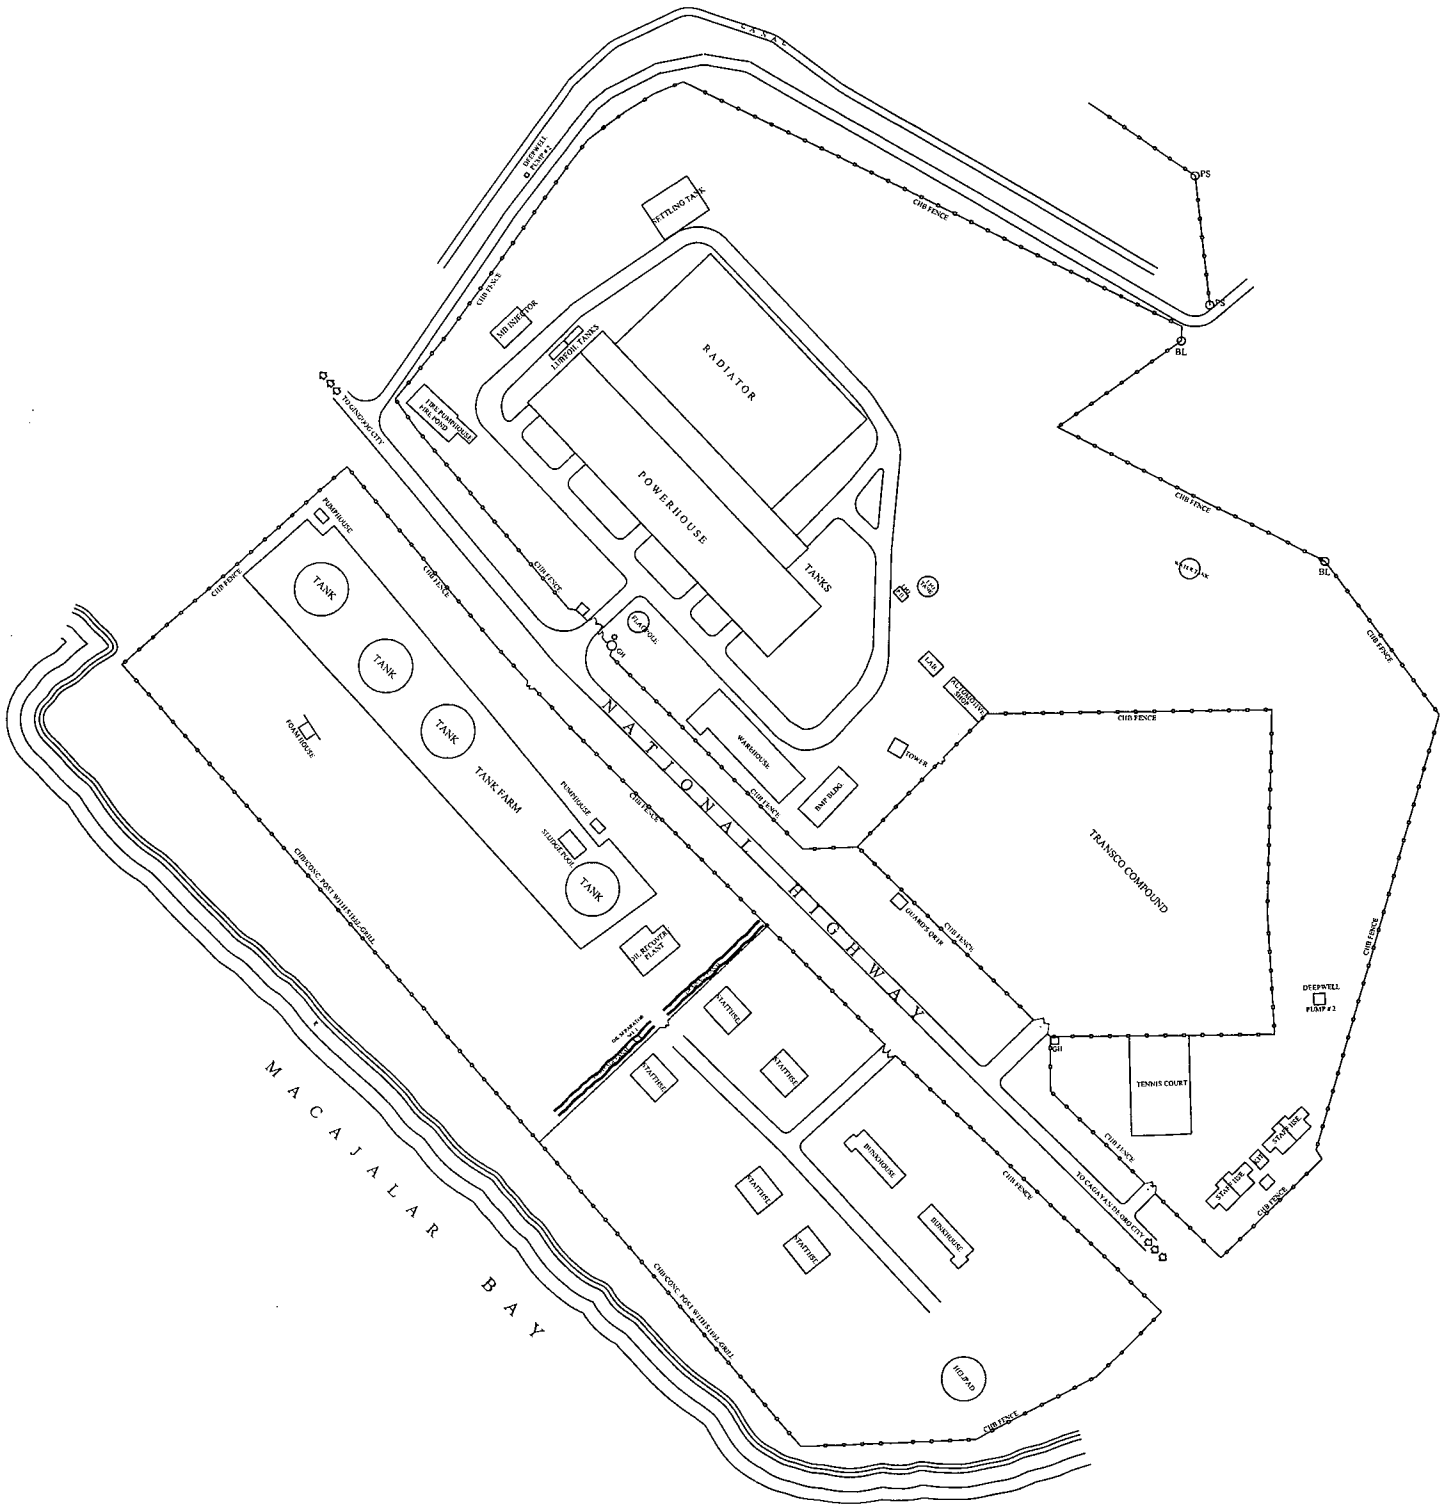

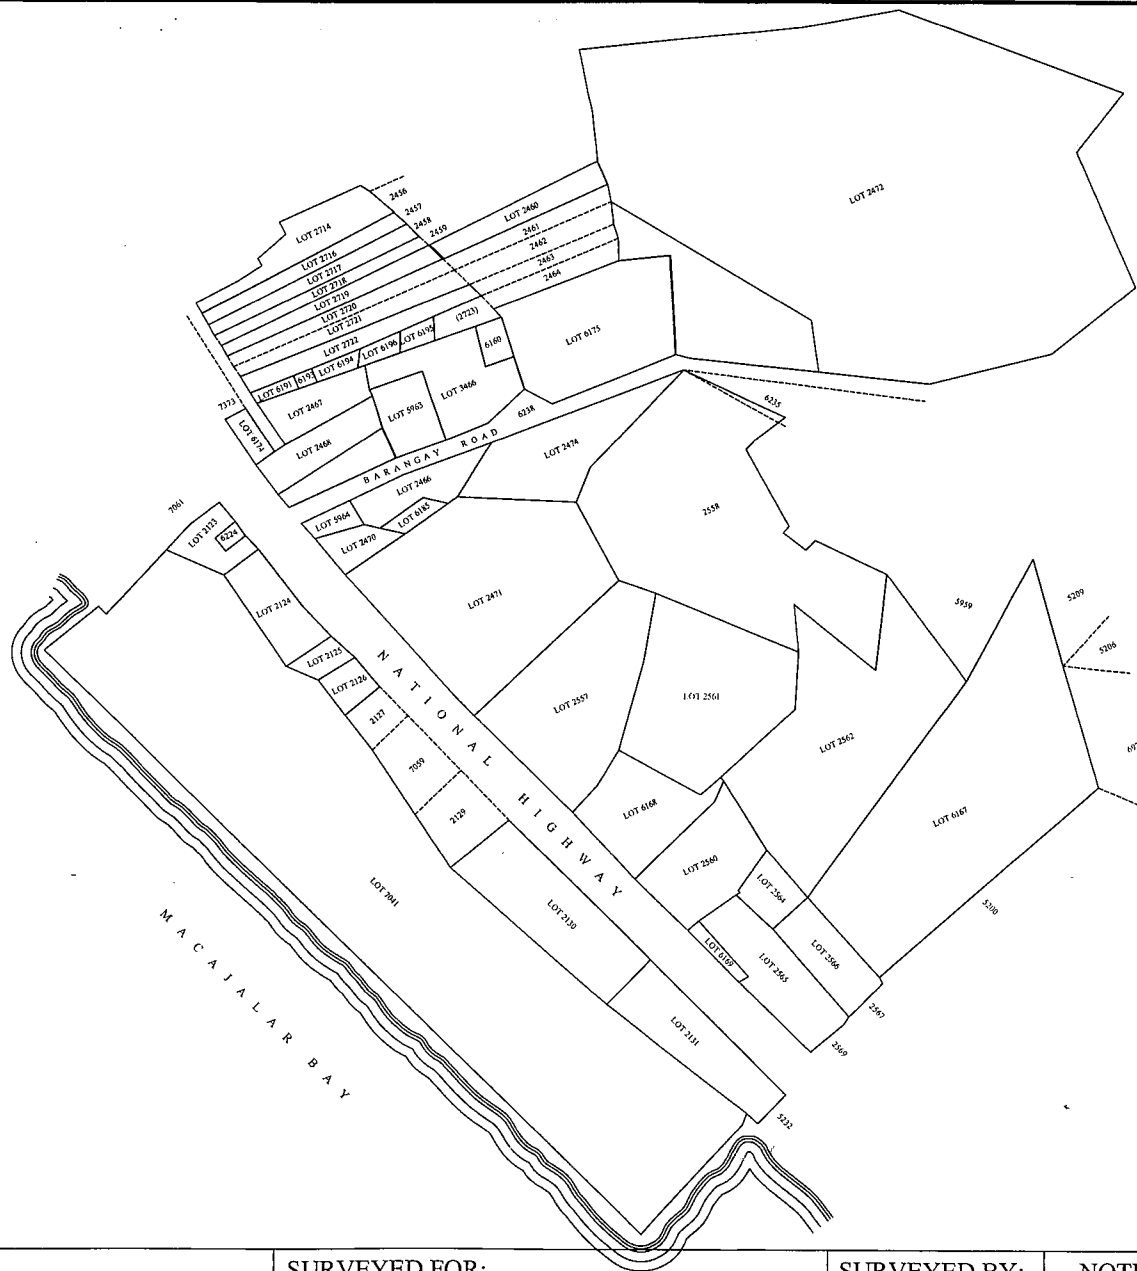
 


| DRAWING TITLE:  | SURVEYED FOR:  | SUBMITTED:                    | CHECKED:                     | VERIFIED:                  | NOTED:                        | SHEET CONTENTS :                                   | SHT |
|---|--|-------------------------------|------------------------------|----------------------------|-------------------------------|--|-----|
| <b>APLAYA DIESEL POWER PLANT</b><br>APLAYA, JASAN, MISAMIS ORIENTAL<br>ACTUAL SURVEY OF EXISTING STRUCTURES |  <b>NATIONAL POWER CORPORATION</b><br>OGC- LAND AND LAND RIGHTS DEPT. | E.A. MAANDIG<br>SR. ENGR -LSD | C. F. ATIENZA<br>LMS-D, LLRD | M.C. ABCEJO<br>LMS-A, LLRD | G.S. MONTOJO<br>MANAGER, LLRD | <b>SKETCH PLAN</b><br>(STRUCTURES AND LOT NUMBERS) | 2   |
|   |  |                               |                              |                            |                               | SCALE: 1:1500 M.                                   | 2   |



| DRAWING TITLE:  | SURVEYED FOR:  | SUBMITTED:                    | CHECKED:                     | VERIFIED:                  | NOTED:                        | SHEET CONTENTS :                            | SHT |
|---|--|-------------------------------|------------------------------|----------------------------|-------------------------------|---|-----|
| <b>APLAYA DIESEL POWER PLANT</b><br>APLAYA, JASAM, MISAMIS ORIENTAL<br>ACTUAL SURVEY OF EXISTING STRUCTURES |  <b>NATIONAL POWER CORPORATION</b><br>OGC- LAND AND LAND RIGHTS DEPT. | E.A. MAANDIG<br>SR. ENGR.-LSD | C. F. ATIENZA<br>LMS-D, LLRD | M.C. ABCEJO<br>LMS-A, LLRD | G.S. MONTOJO<br>MANAGER, LLRD | <b>SKETCH PLAN</b><br>(EXISTING STRUCTURES) | 1   |
|   |  |                               |                              |                            |                               | SCALE: 1:1500 M.                            | 2   |



|  |                            |  |   |                  |        |
|--|----------------------------|--|---|------------------|--------|
| DRAWING TITLE:   | SURVEYED FOR:              | SURVEYED BY:   | NOTED BY:                                       | SHEET CONTENTS : | SHEET  |
| NPC- JASAAN DIESEL POWER PLANT<br>PLOTING OF NPC OCCUPIED PROPERTIES | NATIONAL POWER CORPORATION | E.A. MAANDIG<br>FOR NPC-LSD<br><small>CADD: E.M.GALELA FN: APLAYA.LOTS.dwg</small> | ATTY. H.A.M. SOLAIMAN<br>CORP. ATTY. A, LSD-NPC | SKETCH PLAN      | 1 of 1 |
|  |                            |  |   | SCALE: 1:4000 M  |        |